

 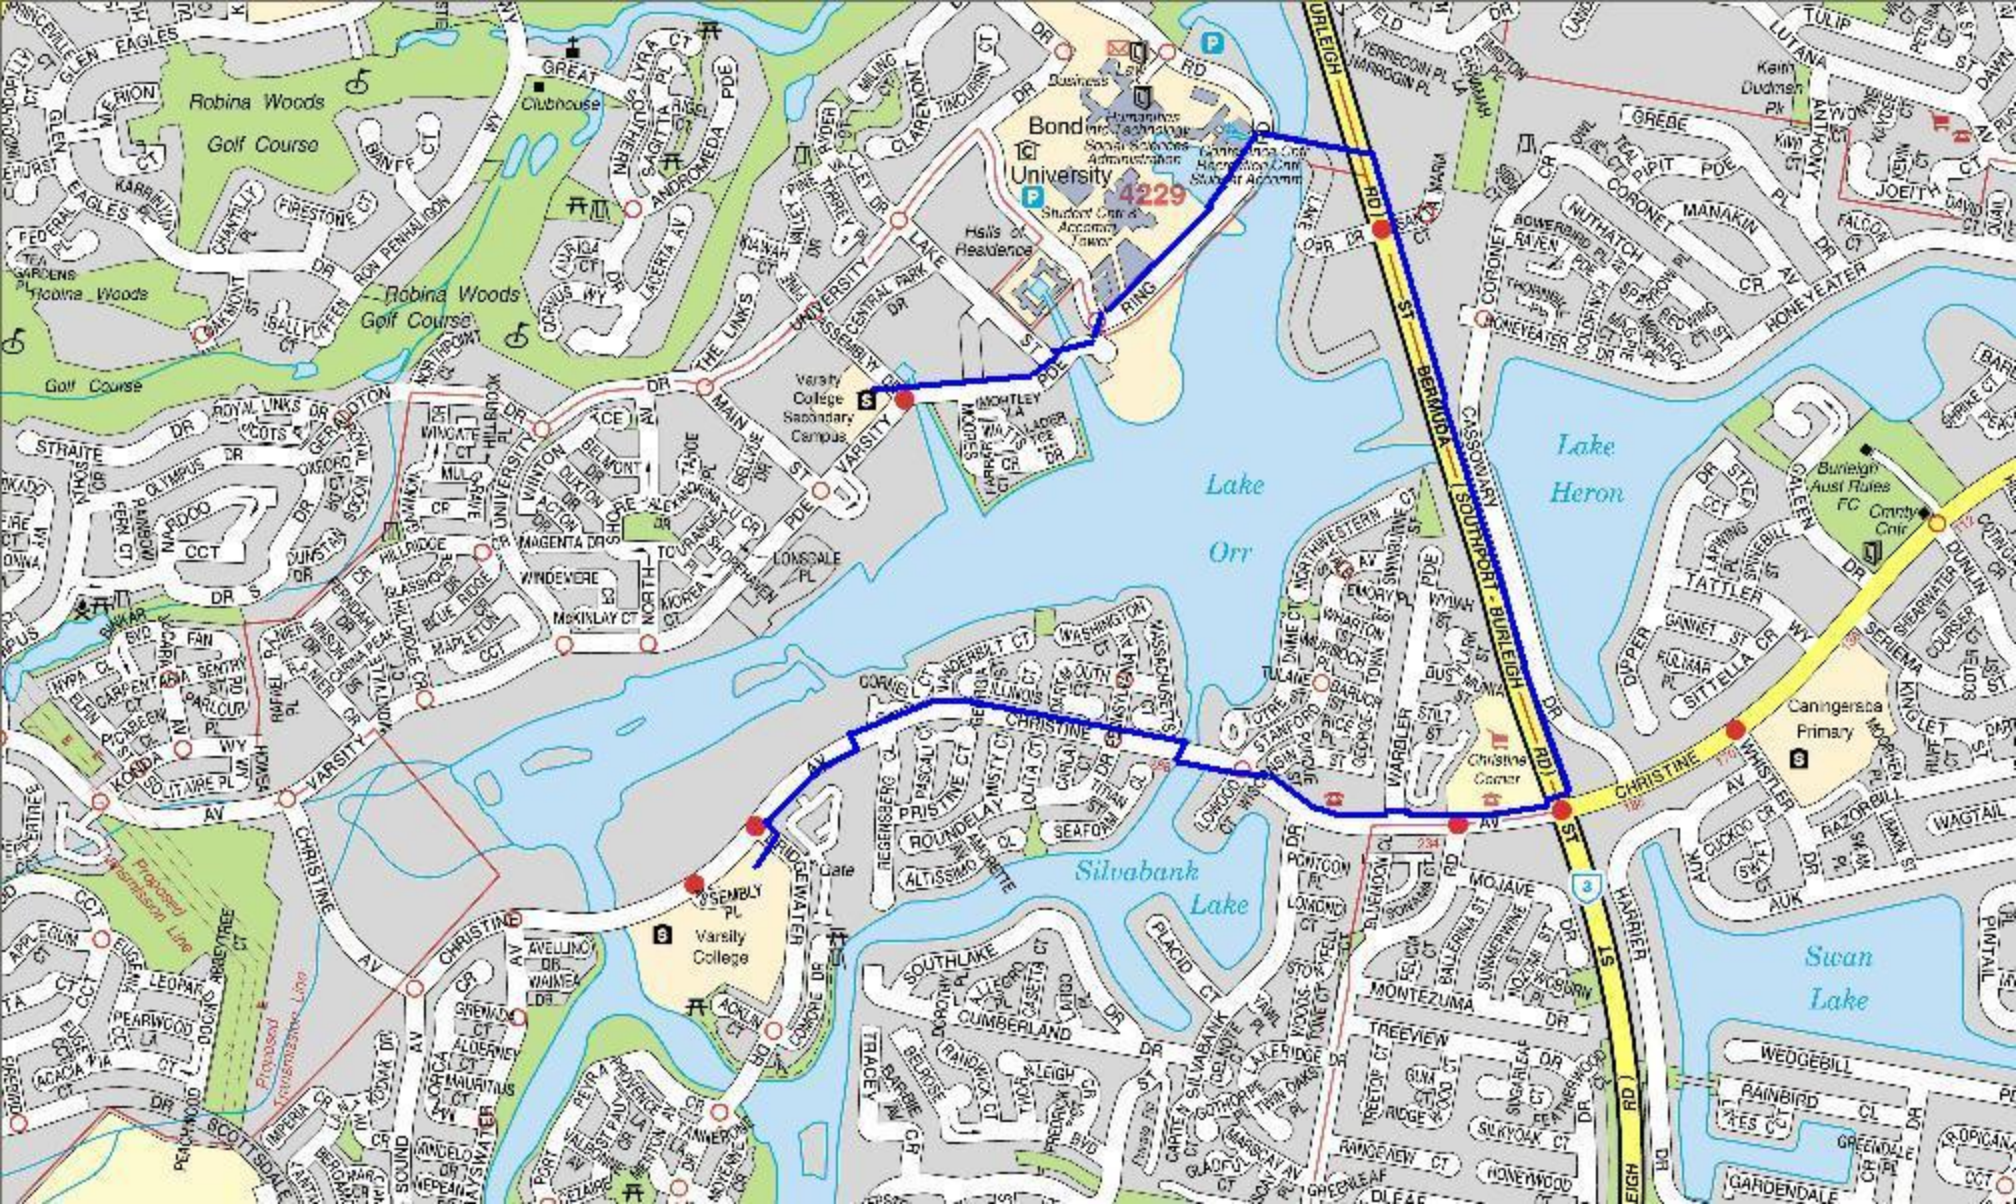


	1	2	3	4	5	6	7	8	9	10	11	12	13	14	15	16
1	UBD - Gold Coast															
2	Map Ref.															
3																
4	59F1															
5	59G1															
6	59H1															
7	49H20															
8	49J20															
9	49J19															
10	49K19															
11	59K1															
12	59L1															
13	59L2															
14	59L3															
15	59L4															
16	59L5															
17	59K5															
18	59J5															
19	59J4															
20	59H4															
21	59G4															
22	59F4															
23	59E4															
24	59E5															
25	59D5															
26	59D6															
27																
28																
29																
30																
31																
32																

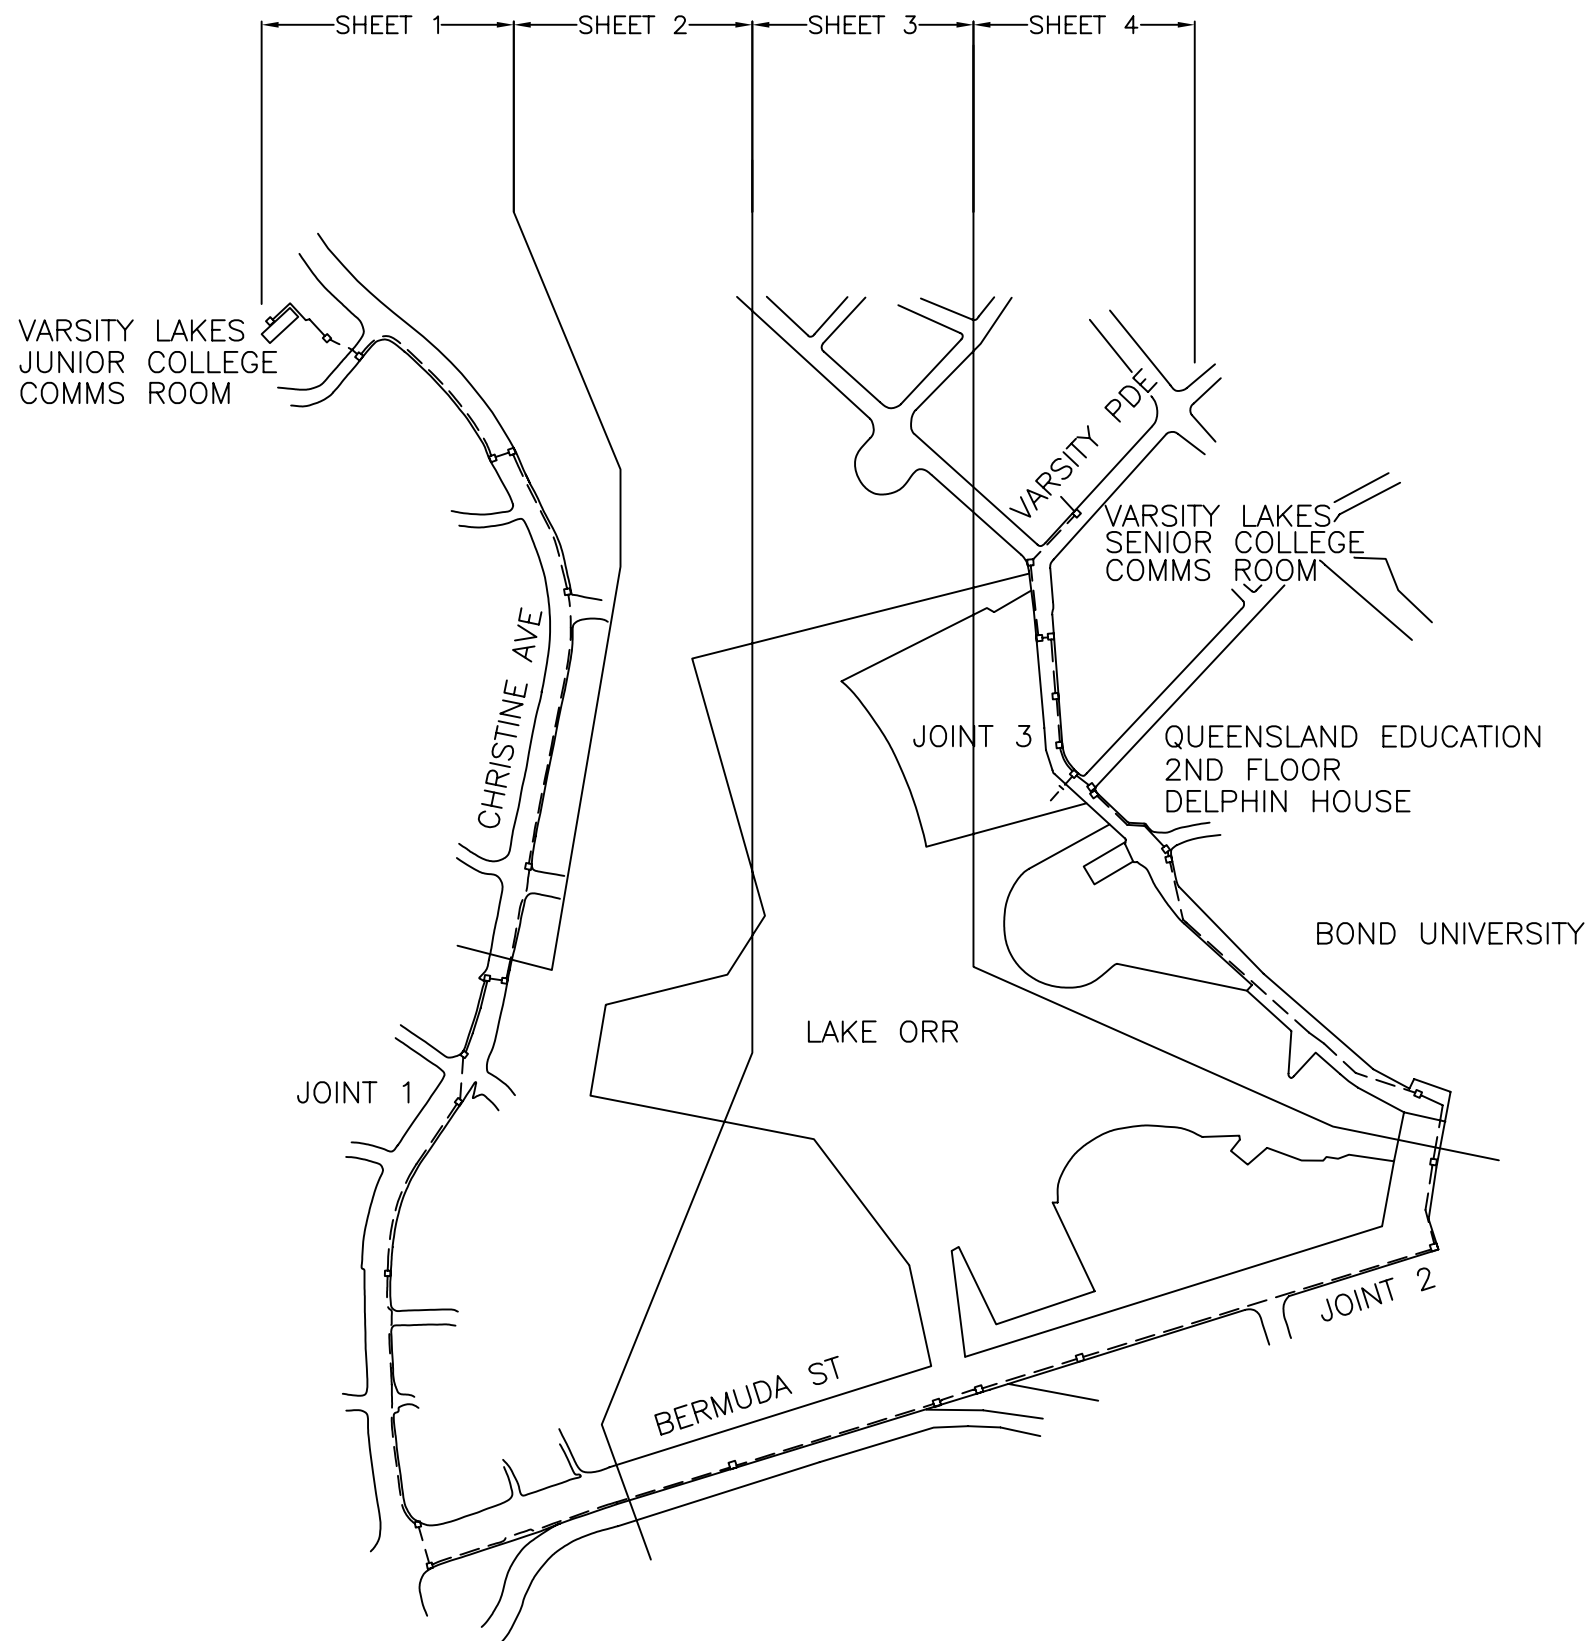



LEGEND

-  COMMUNICATIONS CABINET
-  OPTIC FIBRE IN CONDUIT

This design is Commercial-In-Confidence, and may not be used, duplicated, transferred or stored in or on any media, in whole or part, without the express written permission of COMMUNICATIONS DESIGN & MANAGEMENT PTY LIMITED.

Nov 16, 2004 - 2:12pm

REV	DATE	BY	CHECKED	APPROVED	QA

Client

Education Queensland



School Code

Client Reference:

CDM

COMMUNICATIONS DESIGN & MANAGEMENT PTY LIMITED


Level 3, 380 Queen Street. BRISBANE QLD 4000

GPO Box 791, BRISBANE QLD 4001

Phone: (07) 3221 9033 Fax: (07) 3221 9260


ACN 053 788 720

Title Varsity Lakes State School Fibre Link Overview Site Plan Cabling Diagram			
Designed JW 7-01-02		Drawn CT 5-06-02	
Checked		QA	
APPROVED		CDM Reference:	
Drawing Number 402001-1759-000			Revision -
			Size A3

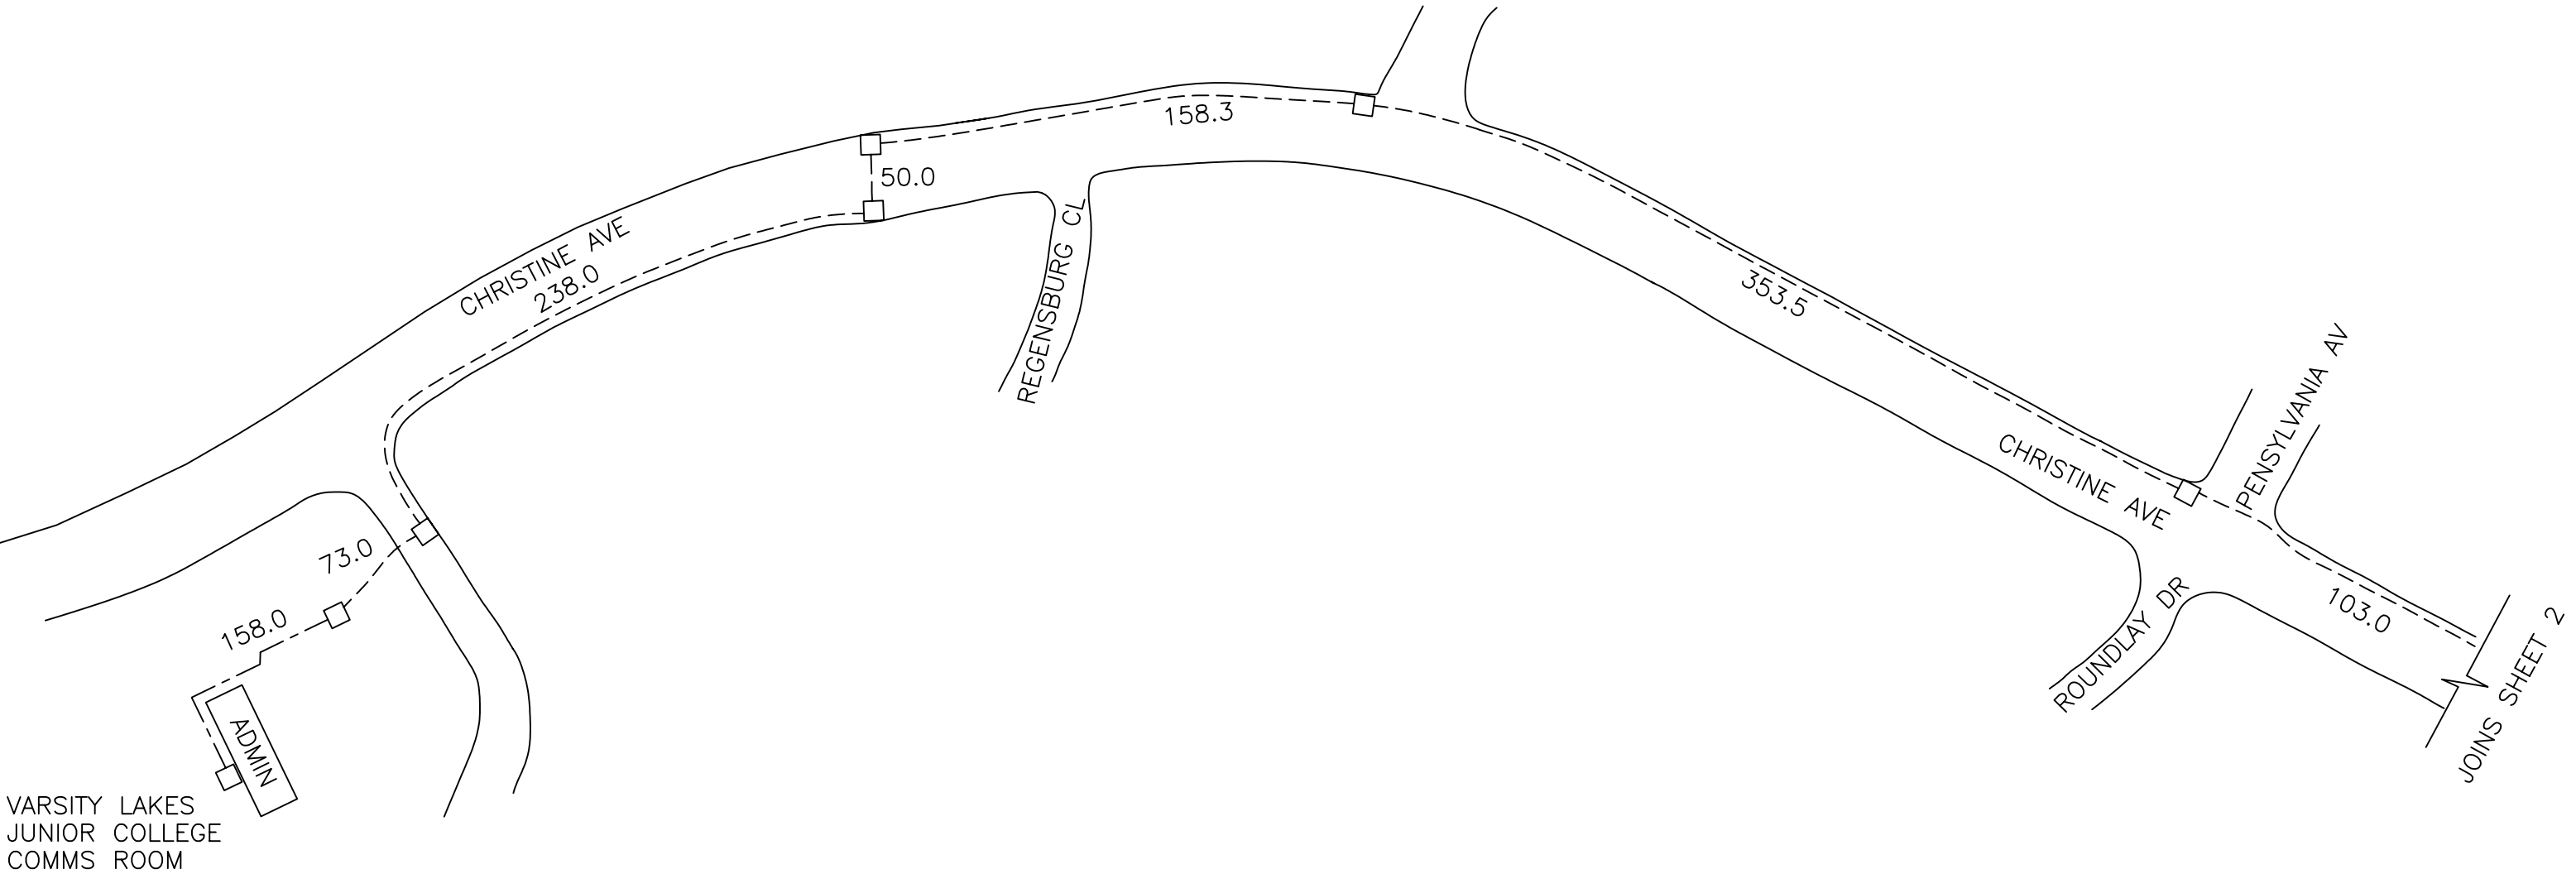

VARSITY LAKES
JUNIOR COLLEGE
COMMS ROOM

LEGEND C COMMUNICATIONS CABINET ----- OPTIC FIBRE IN CONDUIT This design is Commercial-In-Confidence, and may not be used, duplicated, transferred or stored in or on any media, in whole or part, without the express written permission of COMMUNICATIONS DESIGN & MANAGEMENT PTY LIMITED.	REV	DATE	BY	CHECKED	APPROVED	QA	Client Education Queensland		Title VARSITY LAKES STATE SCHOOL FIBRE LINK 1 SITE PLAN CABLING DIAGRAM		
							School Code	Client Reference:	Designed JW 7-01-02	Drawn CT 3-06-02	Scale NTS
							CDM		Checked	QA	Unless otherwise specified, all dimensions are in millimetres.
							COMMUNICATIONS DESIGN & MANAGEMENT PTY LIMITED		APPROVED	CDM Reference:	
							Level 3, 380 Queen Street. BRISBANE QLD 4000 GPO Box 791, BRISBANE QLD 4001 Phone: (07) 3221 9033 Fax: (07) 3221 9260 ACN 053 788 720		Drawing Number 402001-1759-000A	Revision —	

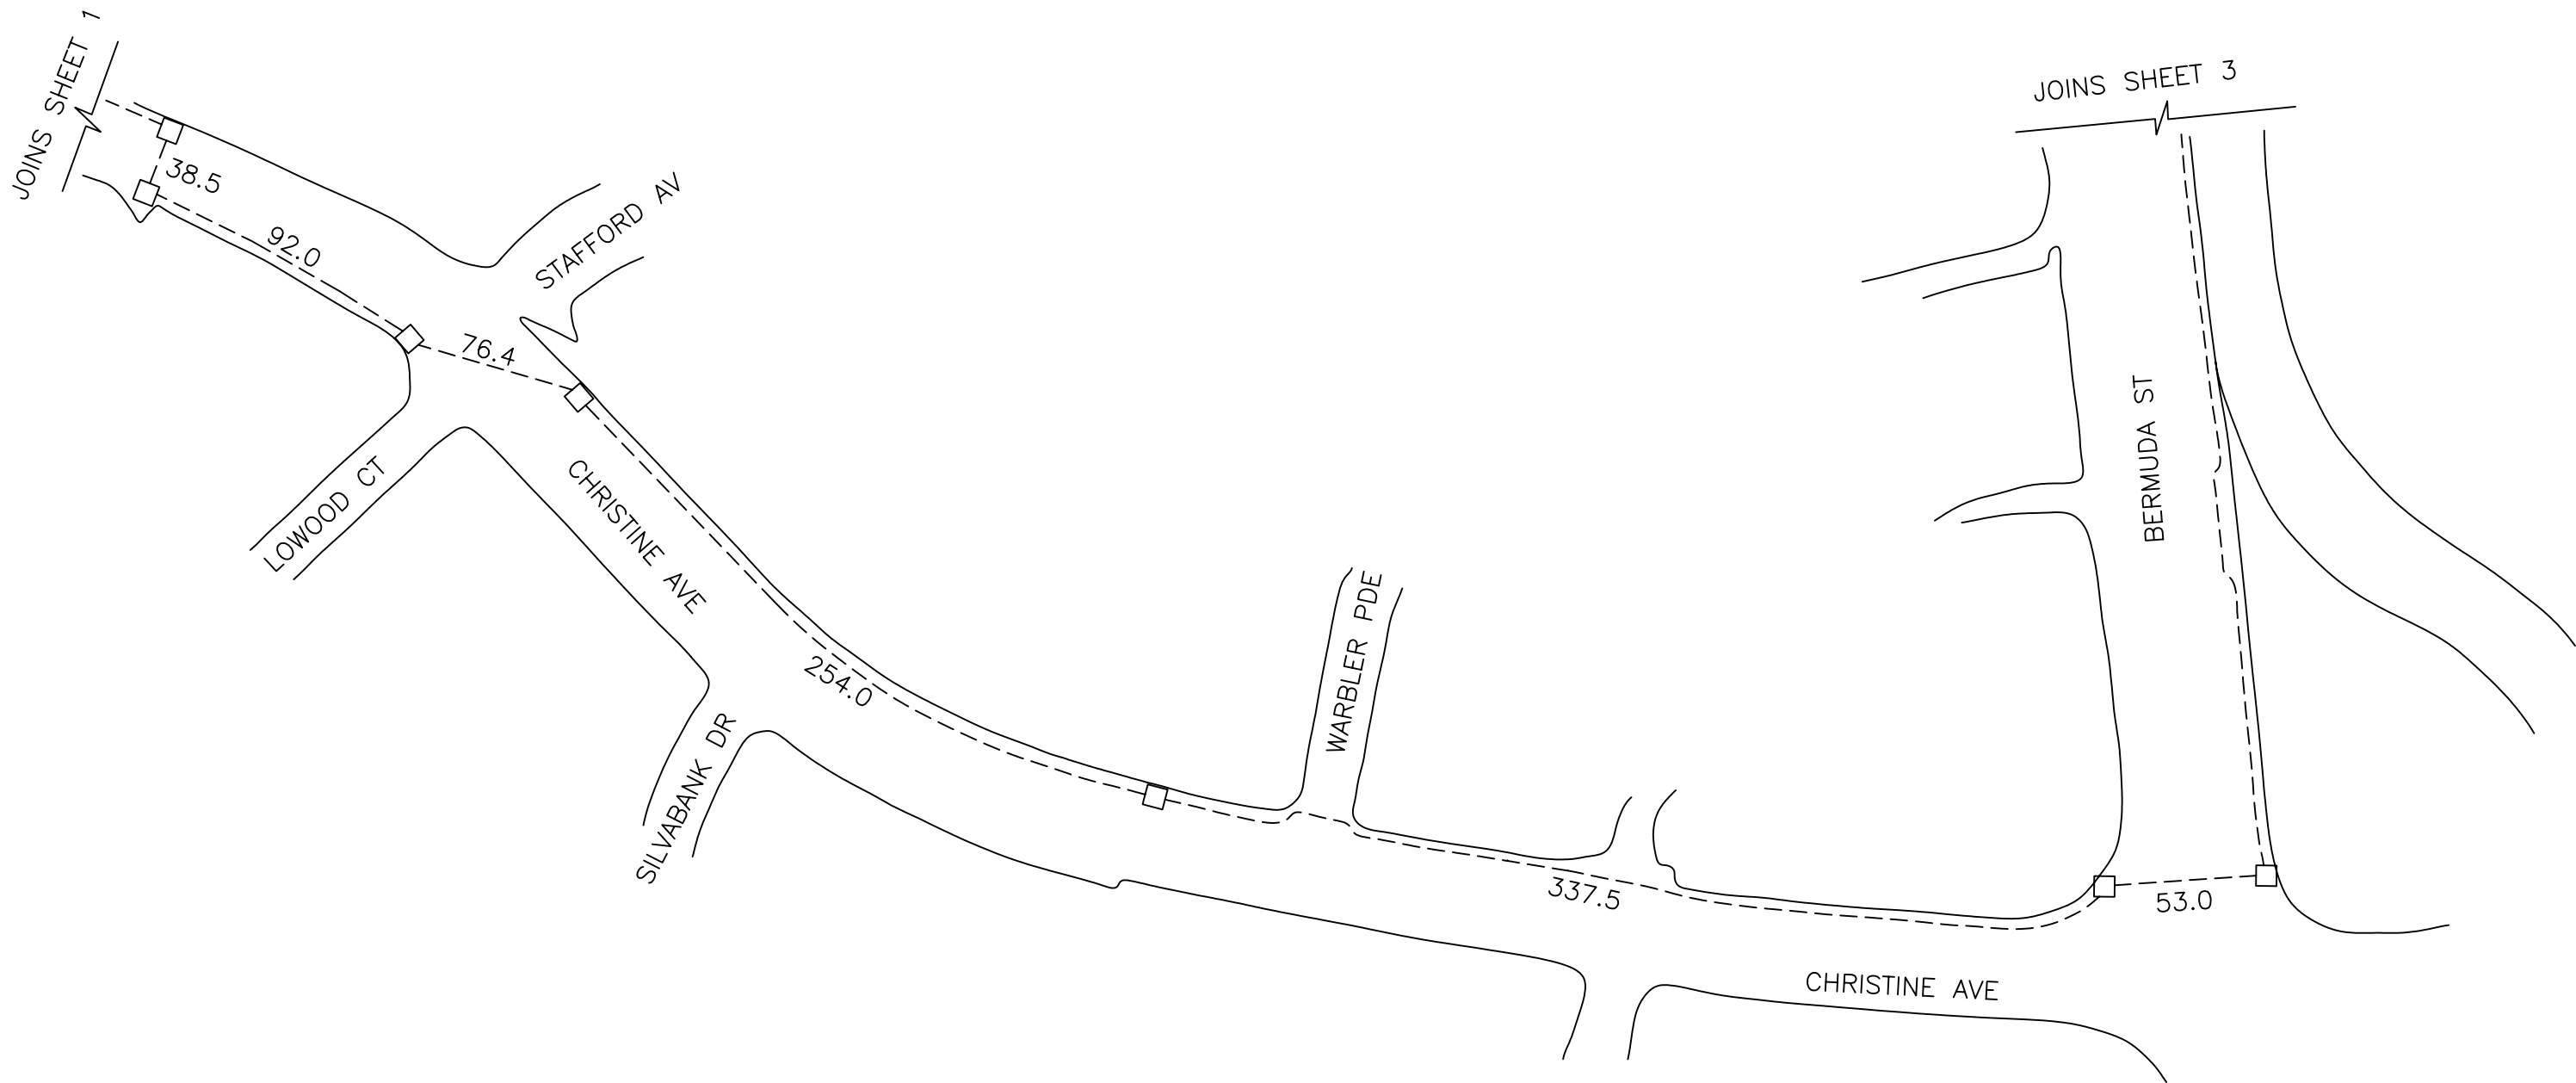

LEGEND

-  COMMUNICATIONS CABINET
- OPTIC FIBRE IN CONDUIT

This design is Commercial-In-Confidence, and may not be used, duplicated, transferred or stored in or on any media, in whole or part, without the express written permission of COMMUNICATIONS DESIGN & MANAGEMENT PTY LIMITED.

REV	DATE	BY	CHECKED	APPROVED	QA

Client

Education

Queensland



School Code

Client Reference:

CDM

COMMUNICATIONS DESIGN & MANAGEMENT PTY LIMITED

Level 3, 380 Queen Street. BRISBANE QLD 4000

GPO Box 791, BRISBANE QLD 4001

Phone: (07) 3221 9033 Fax: (07) 3221 9260

ACN 053 788 720

Title


VARSITY LAKES STATE SCHOOL

FIBRE LINK 2

SITE PLAN

CABLING DIAGRAM

Designed JW 7-01-02	Drawn CT 3-06-02	Scale NTS
Checked	QA	Unless otherwise specified, all dimensions are in millimetres.
APPROVED	CDM Reference:	
Drawing Number 402001-1759-000B		Revision —
		Size A3

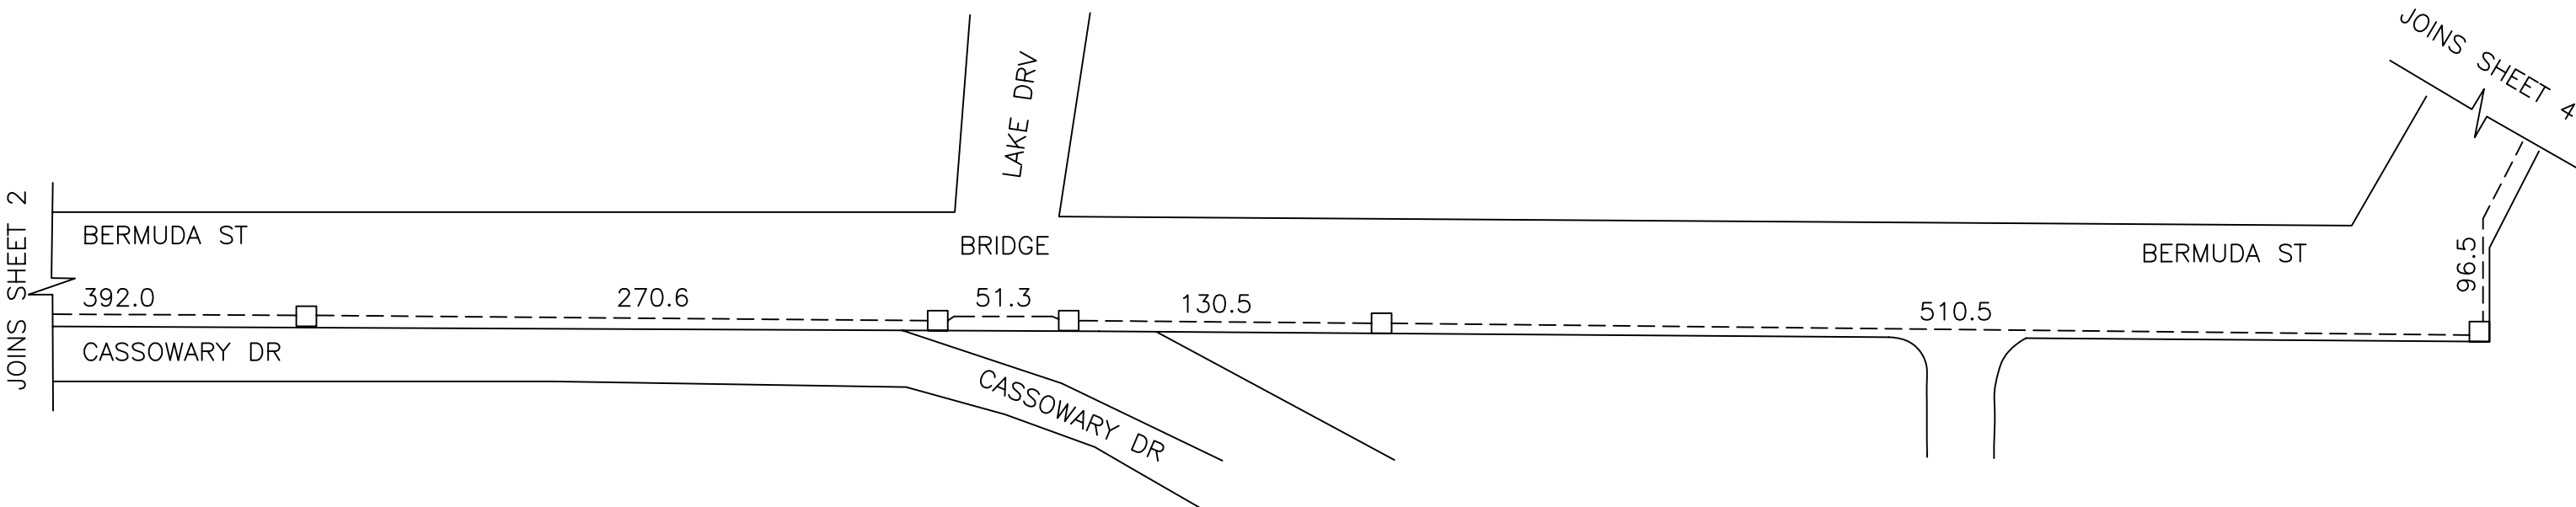

LEGEND

-  COMMUNICATIONS CABINET
- OPTIC FIBRE IN CONDUIT

This design is Commercial-In-Confidence, and may not be used, duplicated, transferred or stored in or on any media, in whole or part, without the express written permission of COMMUNICATIONS DESIGN & MANAGEMENT PTY LIMITED.

REV	DATE	BY	CHECKED	APPROVED	QA

Client

Education

Queensland



School Code

Client Reference:

CDM

COMMUNICATIONS DESIGN & MANAGEMENT PTY LIMITED

Level 3, 380 Queen Street. BRISBANE QLD 4000

GPO Box 791, BRISBANE QLD 4001

Phone: (07) 3221 9033 Fax: (07) 3221 9260

ACN 053 788 720

Title

VARSITY LAKES STATE SCHOOL

FIBRE LINK 3

SITE PLAN

CABLING DIAGRAM

Designed

JW 7-01-02

Checked

APPROVED

Drawn

CT 3-06-02

QA

CDM Reference:

Scale

NTS

Unless otherwise specified, all dimensions are in millimetres.

Drawing Number


402001-1759-000C

Revision

—

Size

A3

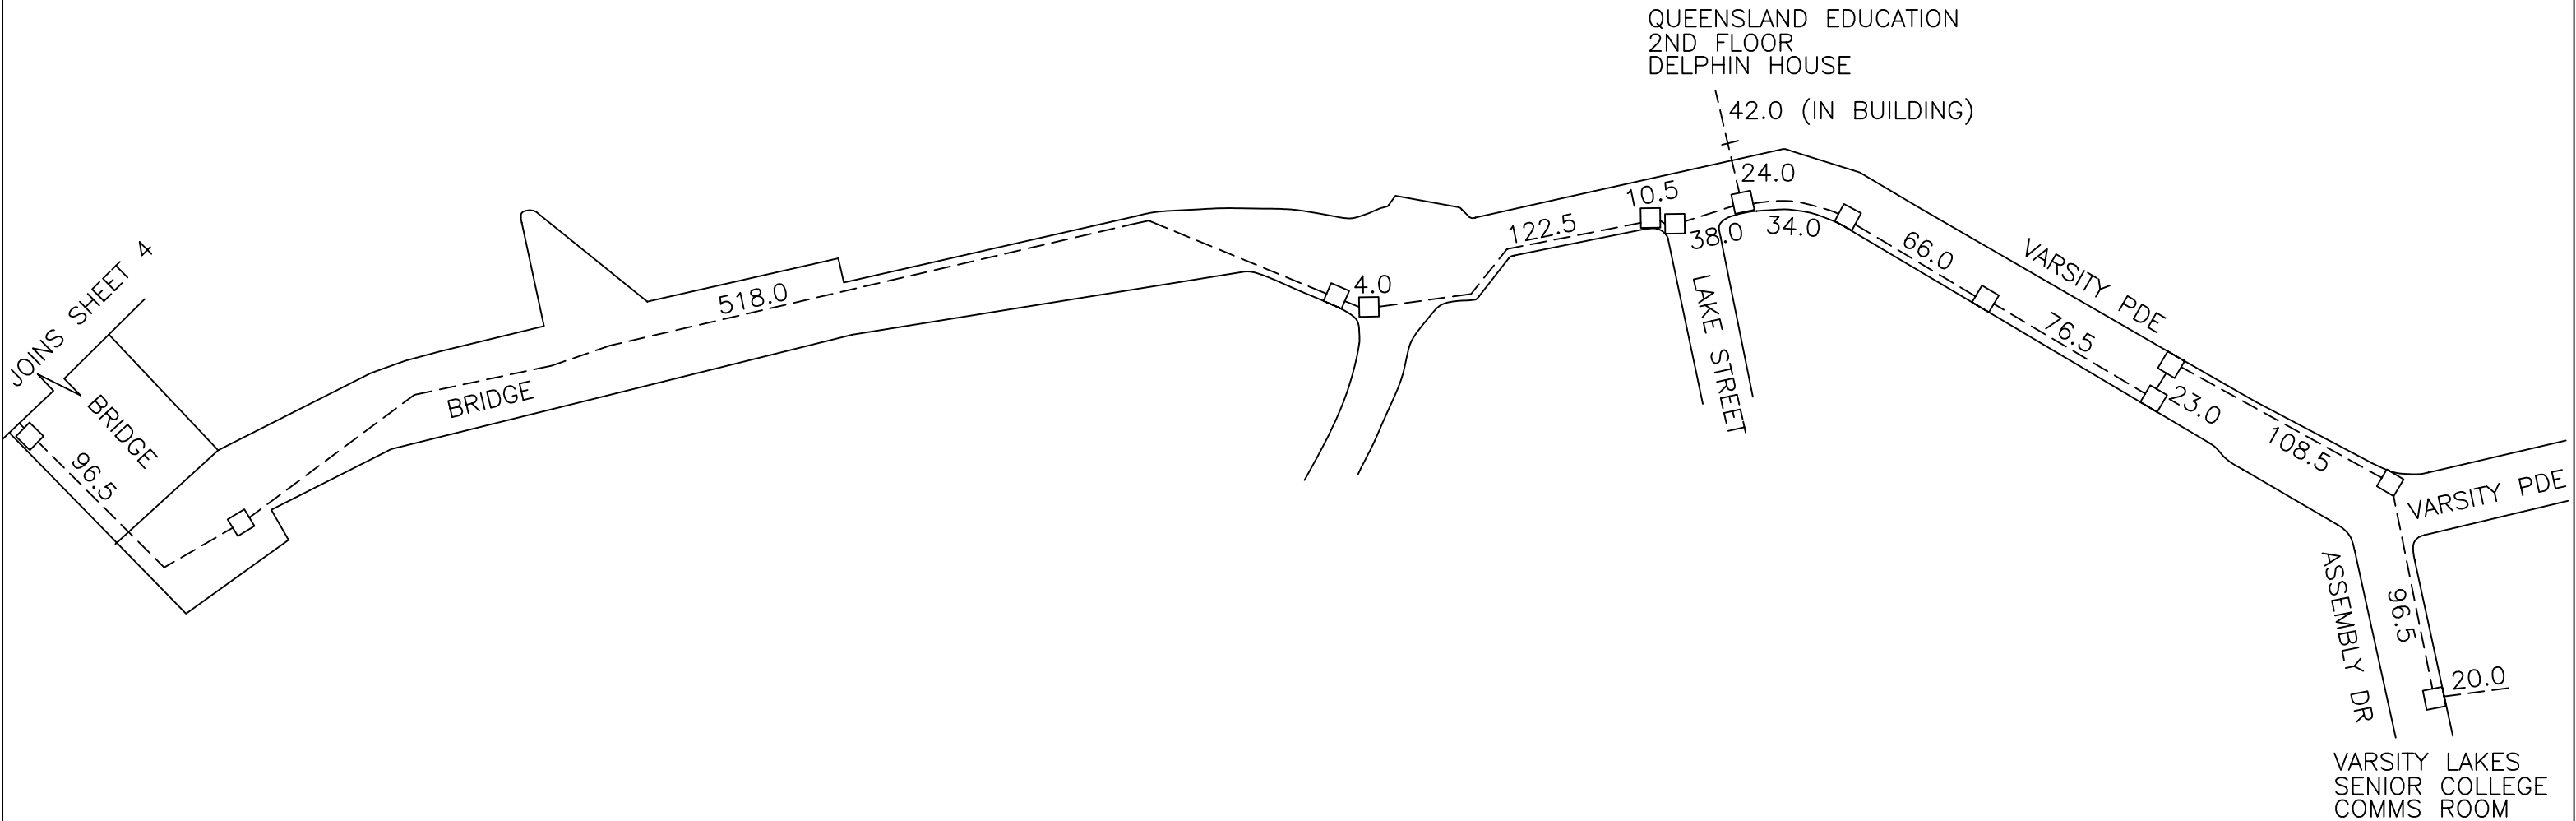

LEGEND

-  COMMUNICATIONS CABINET
- OPTIC FIBRE IN CONDUIT

This design is Commercial-In-Confidence, and may not be used, duplicated, transferred or stored in or on any media, in whole or part, without the express written permission of COMMUNICATIONS DESIGN & MANAGEMENT PTY LIMITED.

REV	DATE	BY	CHECKED	APPROVED	QA

Client

Education Queensland



School Code

Client Reference:

CDM

COMMUNICATIONS DESIGN & MANAGEMENT PTY LIMITED

Level 3, 380 Queen Street. BRISBANE QLD 4000

GPO Box 791, BRISBANE QLD 4001

Phone: (07) 3221 9033 Fax: (07) 3221 9260

ACN 053 788 720

Title

VARSITY LAKES STATE SCHOOL
FIBRE LINK 4
SITE PLAN
CABLING DIAGRAM

Designed
JW 7-01-02

Drawn
CT 3-06-02

Scale
NTS

Checked

QA

Unless otherwise specified, all dimensions are in millimetres.

APPROVED

CDM Reference:

Drawing Number

Revision

Size

402001-1759-000D

-

A3